


ELECTRICAL LEGEND:	
SYMBOL	DESCRIPTION
	SINGLE WALL SWITCH
	1/2 V. DUPLEX OUTLET
	WALL FIXTURE W/ HIGH-EFFICACY LIGHTING
	RECESSED LIGHTING W/ HIGH-EFFICACY LIGHTING
	CEILING FIXTURE W/ HIGH-EFFICACY LIGHTING
	FLUORESCENT LIGHTING
	SMOKE DETECTOR HARD WIRED W/ BATTERY BACKUP
	CARBON MONOXIDE ALARM HARD WIRED W/ B. B.-UP
	TELEPHONE OUTLET
	T.V. CABLE
	CEILING FAN W/ HIGH-EFFICACY LIGHTING
	EXHAUST FAN W/ FLUORESCENT LIGHT (50 CFM MIN)
	Ground fault circuit interrupter
	Waterproof Deck to Drive - Photo control motion sensor
	Arc fault circuit interrupter-temper proof


ABBREVIATIONS:  
(E) EXISTING  
(N) NEW

LEGEND:  
 EXISTING BUILDING  
 EXISTING WALLS  
 NEW WALLS  
 BASEMENT  
 BASEMENT WALLS

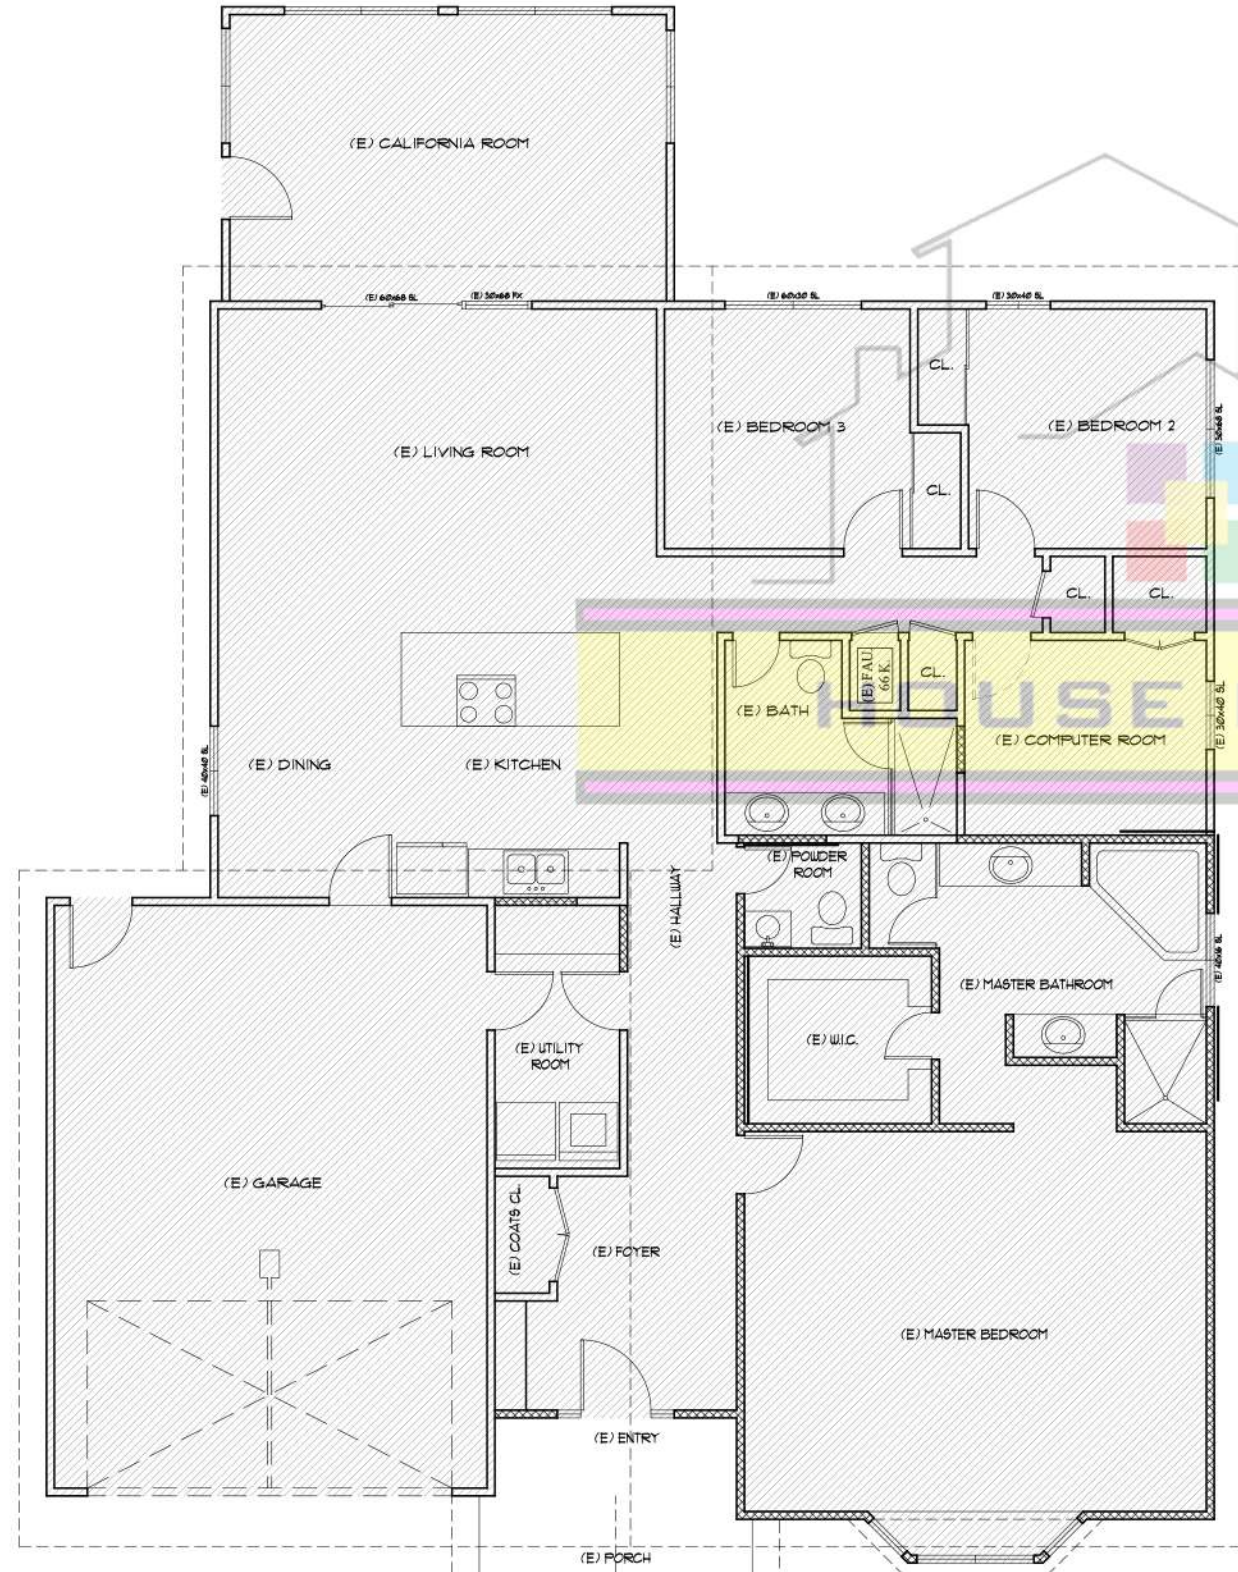

**FLOOR PLAN (EXISTING)**

SCALE: 1/4" = 1'

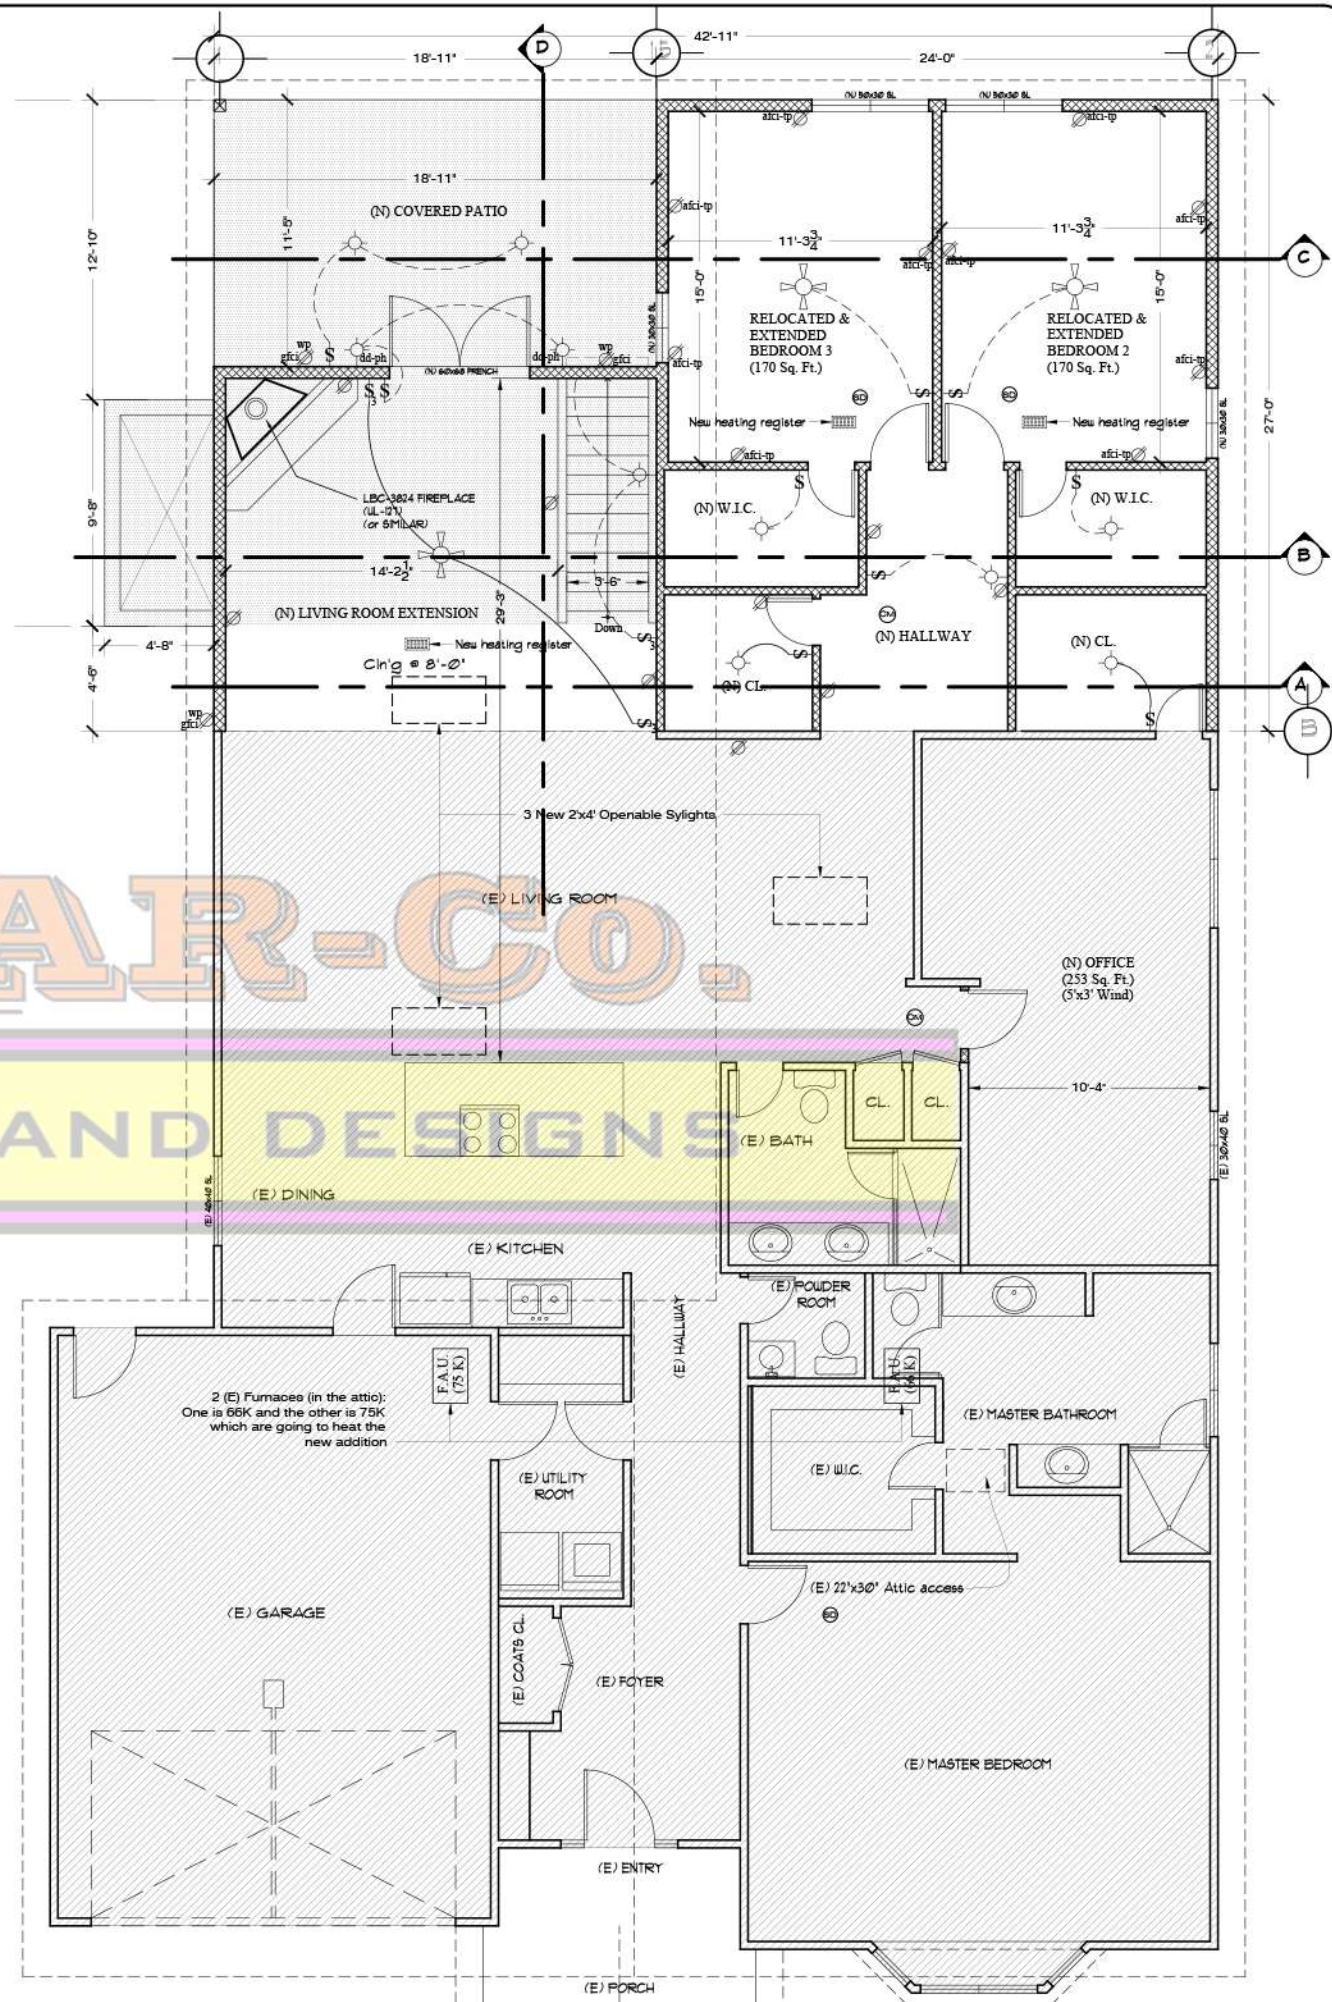

**FLOOR PLAN (REMODELED)**

SCALE: 1/4" = 1'

MAR-CO.  
HOUSE PLANS AND DESIGNS

**MAR-CO.**  
 HOUSE PLANS & DESIGNS  
 HOUSE PLANS & DESIGNS  
 MARCO A. LAUREANO  
 PLANS: 0610-0-0000-30-PERMISS  
 MARCO A. LAUREANO  
 1500 W. SAN MARCO AVE. SUITE 100  
 SAN MARCO, CA 92078  
 WWW.MARCOHOUSEPLANS.COM  
 760.941.2878  
 760.941.2879

OWNERS NAME & ADDRESS:  
**MR. & MRS. BLAKEY**  
 XXXX LAKE ASHWOOD AVE. SAN DIEGO, CA. 92119

PROJECT NAME & ADDRESS:  
**BLAKEYS HOUSE REMODEL**  
 XXXX LAKE ASHWOOD AVE. SAN DIEGO, CA. 92119

CONSULTANT:

REVISIONS:  
 A 07/24/2013  
 B 08/01/2013  
 DATE: **06/17/2013**  
 SCALE: AS SPECIFIED  
 DRAWN & PREPARED BY: MARCO A. LAUREANO  
 SHEET: **A-1**  
 OF: **14**